


P3
HARDSCAPE PLAN
SCALE - 1:100

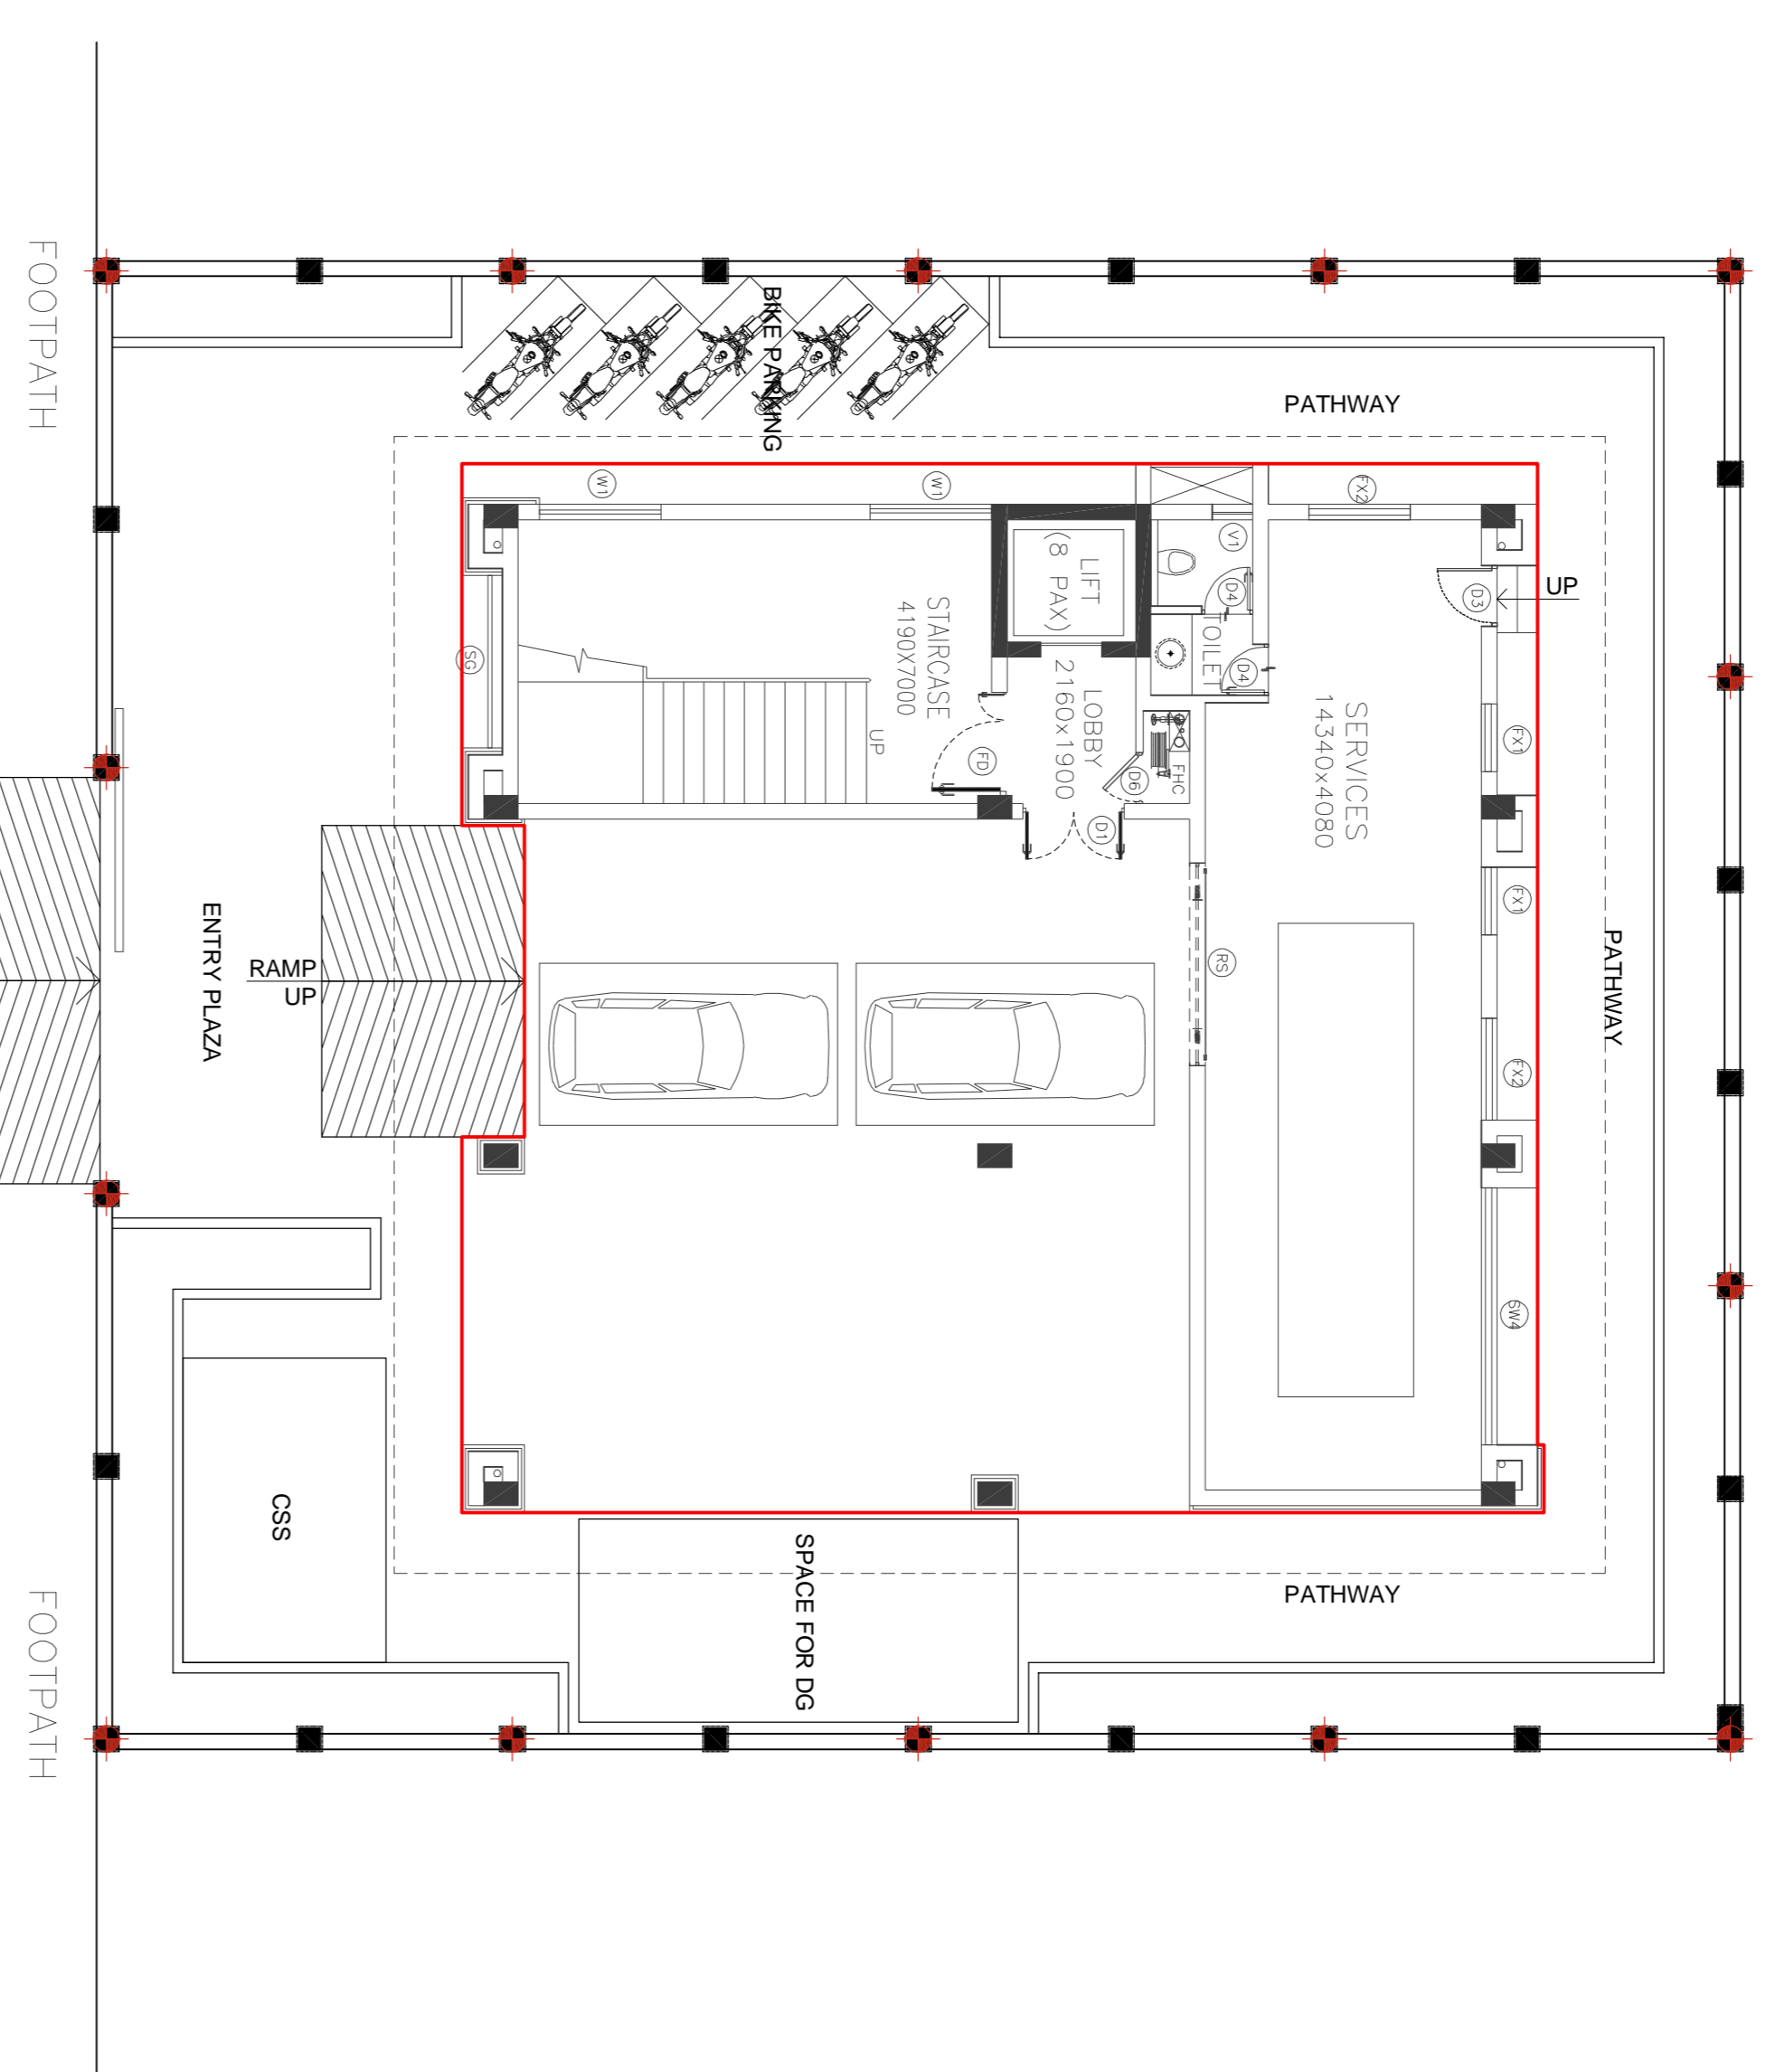

P4
LIGHTING PLAN
SCALE - 1:100

HARDSCAPE LEGEND

SR	SYMBOL	DESCRIPTION	QUANTITY
1.	[Symbol]	Interlocking 60mm thick Concrete pavers (Dark Gray)	75 sqm
2.	[Symbol]	Interlocking 60mm thick Concrete pavers Brick pavers (Light Gray)	70 sqm
3.	[Symbol]	Interlocking 60mm thick Concrete pavers Brick pavers (Red)	10 sqm
4.	[Symbol]	Polished Black Granite (150 mm wide band)	20 sqm
5.	[Symbol]	Flamed Granite (18mm thick)	50 sqm
6.	[Symbol]	Polished Tan Brown Granite (25mm thick)	30 sqm

LIGHTING LEGEND

SR	SYMBOL	DESCRIPTION	QUANTITY
1.	[Symbol]	GATE LIGHT	14 NOS.

GOOD FOR CONSTRUCTION

DO NOT SCALE

P: PRELIMINARY ISSUES ARE NOT TO BE USED FOR CONSTRUCTION. FABRICATION WORK IS PERMITTED ON R: BLOCK ABOVE THIS BLOCK.
CONSTRUCTION / FABRICATION WORK IS PERMITTED ON R: RELEASED) ISSUES ONLY.
INFORMATION CONTAINED WITHIN HOLD IS NOT RELEASED DESIGN OFFICE TO CLEAR HOLDERS IN THE BEFORE PROCEEDING WITH ANY CONSTRUCTION / FABRICATION WORK RELATED TO HOLD.
Proprietary rights of the information contained herein belong to TCE. This in case of misuse of information and any claim arising therefrom, consent and cooperation will be on the party misusing the information.

FILE NAME : TCE.10477A-AC-1007-LP-10402-R0

ISSUE	DRN	DSN	CHD	CV	EL	IC	ME	PL	HW	EXT	LS	PE/PM	APPD	DATE

GUWAHATI SMART CITY LIMITED
SMART CITY MISSION GUWAHATI

HARDSCAPE PLAN AND LIGHTING PLAN

TATA CONSULTING ENGINEERS LIMITED
MUMBAI

SCALE : 1:100
DWG NO. TCE.10477A-LP-1018-LP-10402
DC & DISC: DEL-AC
ISSUE: R0
FILE NAME : TCE.10477A-AC-1007-LP-10402-R0